


ORIGINAL SIZE OF THIS DRAWING IS A3

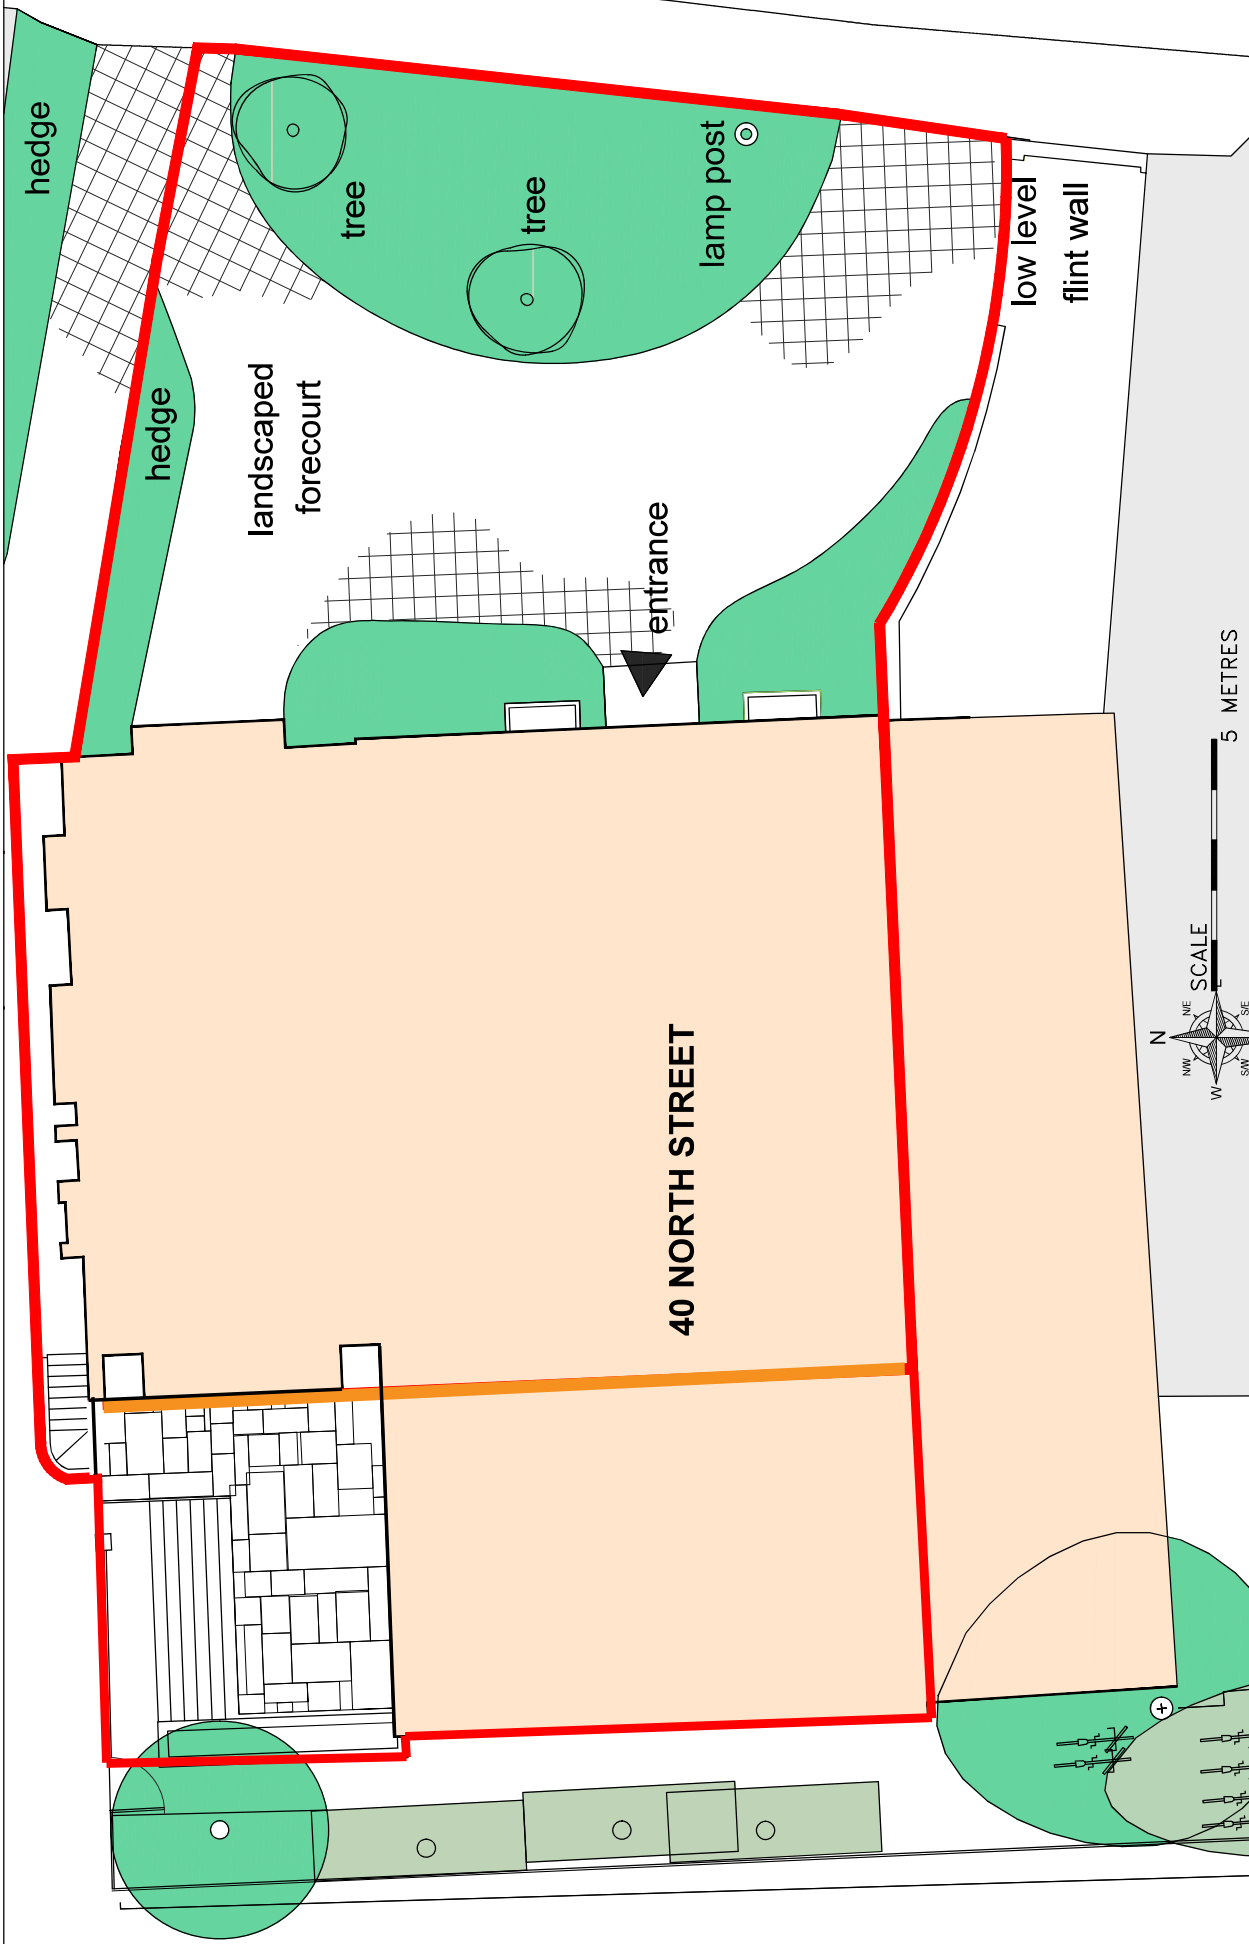

PROJECT		CLIENT	
40, North Street, Chichester		Cottrell	
DRAWING TITLE		COMPUTER FILE NAME	
Site Plan as Proposed		DWG.DWG	
		ORIGINAL SIZE OF THIS DRAWING IS A3	
		DRAWING NUMBER	
DRAWN	CHECKED DATE	PROJECT NUMBER	ACTUAL DRAWING NUMBER
BD	MB Jan 2022	1766	SK
SCALE - AS SCALE RODS		REVISION	
1:100		-	
TRINITY, STRETTON, CHICHESTER, WEST SUSSEX, PO18 0LA, UNITED KINGDOM. TEL: 01243 771166			

E-mail: michael@admarchitects.co.uk
 web site: www.admarchitects.co.uk

Luckes at No.40
40 North Street, Chichester, PO19 1LX


NOTES: 1. DO NOT SCALE FROM THIS DRAWING (EXCEPT FOR PLANNING APPLICATION PURPOSES). 2. ALL DIMENSIONS AND LEVELS TO BE CHECKED ON SITE BEFORE CARRYING OUT WORK. 3. THE ARCHITECTS ACCEPT NO LIABILITY FOR THE ACCURACY OF THE INFORMATION SHOWN ON THIS DRAWING AND THE DESIGN OF THE BUILDING SHOWN ON THIS DRAWING IS VESTED IN THE ARCHITECTS WHOSE PRIOR WRITTEN CONSENT IS REQUIRED FOR ITS USE, REPRODUCTION OR FOR COPYING TO ANY THIRD PARTY.

REVISIONS

REV.	DATE	REVISIONS

© COPYRIGHT - ALL RIGHTS RESERVED
 ARCHITECTS DESIGN & MANAGEMENT

ORIGINAL SIZE OF THIS DRAWING IS A1

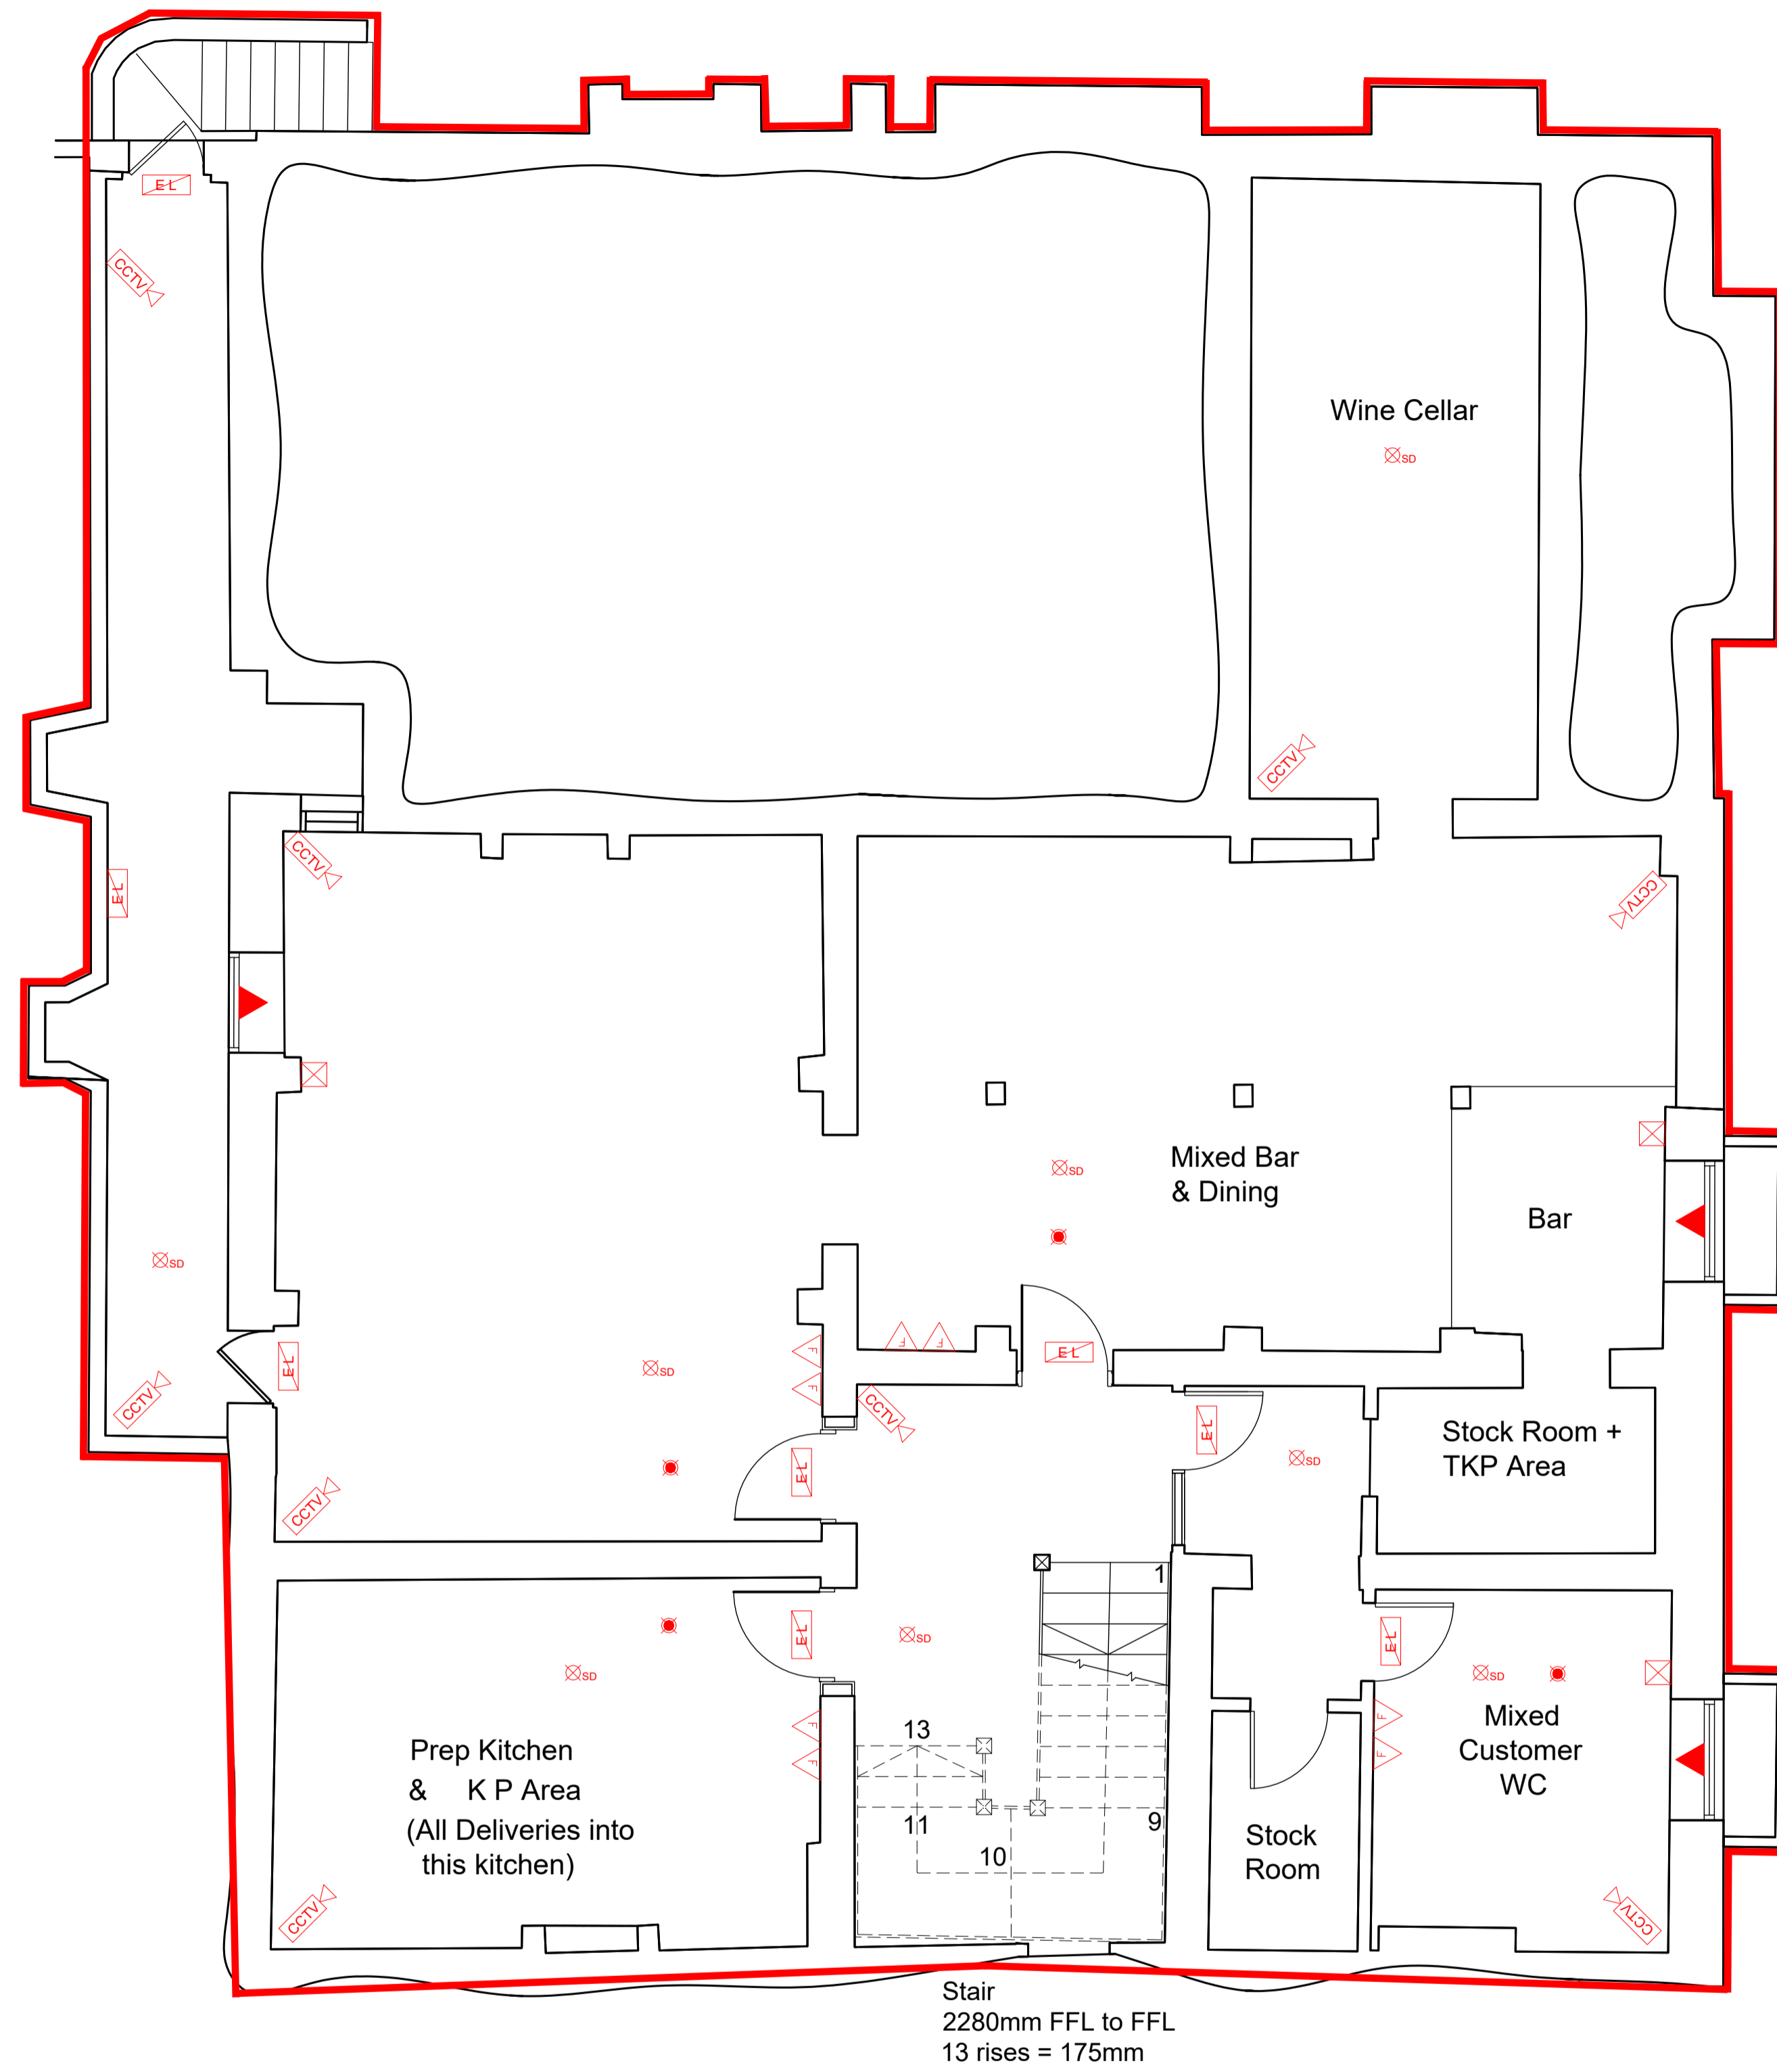

KEY

	CCTV CAMERA		FIRE ALARM CONTROL PANEL
	EMERGENCY LIGHT		BREAK GLASS CALL POINT - LINKED TO FIRE ALARM AUDIBLE WARNING DEVICE
	RED ALARM LIGHT		WALL MOUNTED AIR CON UNIT
	SMOKE DETECTOR		SECURITY ALARM SET PANEL
	FIRE EXTINGUISHER		COMPUTER SERVER UNIT
	AIR CON UNIT CEILING MOUNTED		TELEPHONE POINT
	SECURITY DETECTOR		ELECTRICAL FUSE UNIT
	WINDOW SECURITY DETECTOR		
	MAGNETIC DOOR HOLD OPEN LINKED TO FIRE ALARM		

E-mail michael@admarchitects.co.uk
web site www.admarchitects.co.uk


PROJECT 40, North Street, Chichester				CLIENT Cottrell			
DRAWING TITLE Basement Floor Plan as Proposed				COMPUTER FILE NAME DWG.DWG			
DRAWING NUMBER 1766				ORIGINAL SIZE OF THIS DRAWING IS A1			
DRWN	CHECKED	DATE	SCALE - AS SCALE R/O/S	PROJECT NUMBER	ACTUAL DRAWING NUMBER	REVISION	
BD	MB	Jan' 2022	1:50	1766	SK	-	
TRINITY, STRETCHINGTON, CHICHESTER, WEST SUSSEX, PO18 0LA, UNITED KINGDOM.				TEL. 01243 771166			

ARCHITECTS
DESIGN
&
MANAGEMENT

© COPYRIGHT - ALL RIGHTS RESERVED

NOTES: 1. DO NOT SCALE FROM THIS DRAWING (EXCEPT FOR PLANNING APPLICATION PURPOSES). 2. ALL DIMENSIONS AND LEVELS TO BE CHECKED ON SITE BEFORE CARRYING OUT WORK. 3. ALL DISCREPANCIES TO BE REPORTED TO THE ARCHITECT BEFORE CARRYING OUT WORK. 4. READ WITH OTHER CONTRACT DOCUMENTS S.I.F IN DOUBT ASK. COPY RIGHT & OWNERSHIP OF THIS DRAWING AND THE DESIGN OF THE BUILDING SHOWN ON THIS DRAWING IS VESTED IN THE ARCHITECTS WHOSE PRIOR WRITTEN CONSENT IS REQUIRED FOR ITS USE, REPRODUCTION OR FOR COPYING TO ANY THIRD PARTY.

ORIGINAL SIZE OF THIS DRAWING IS A1

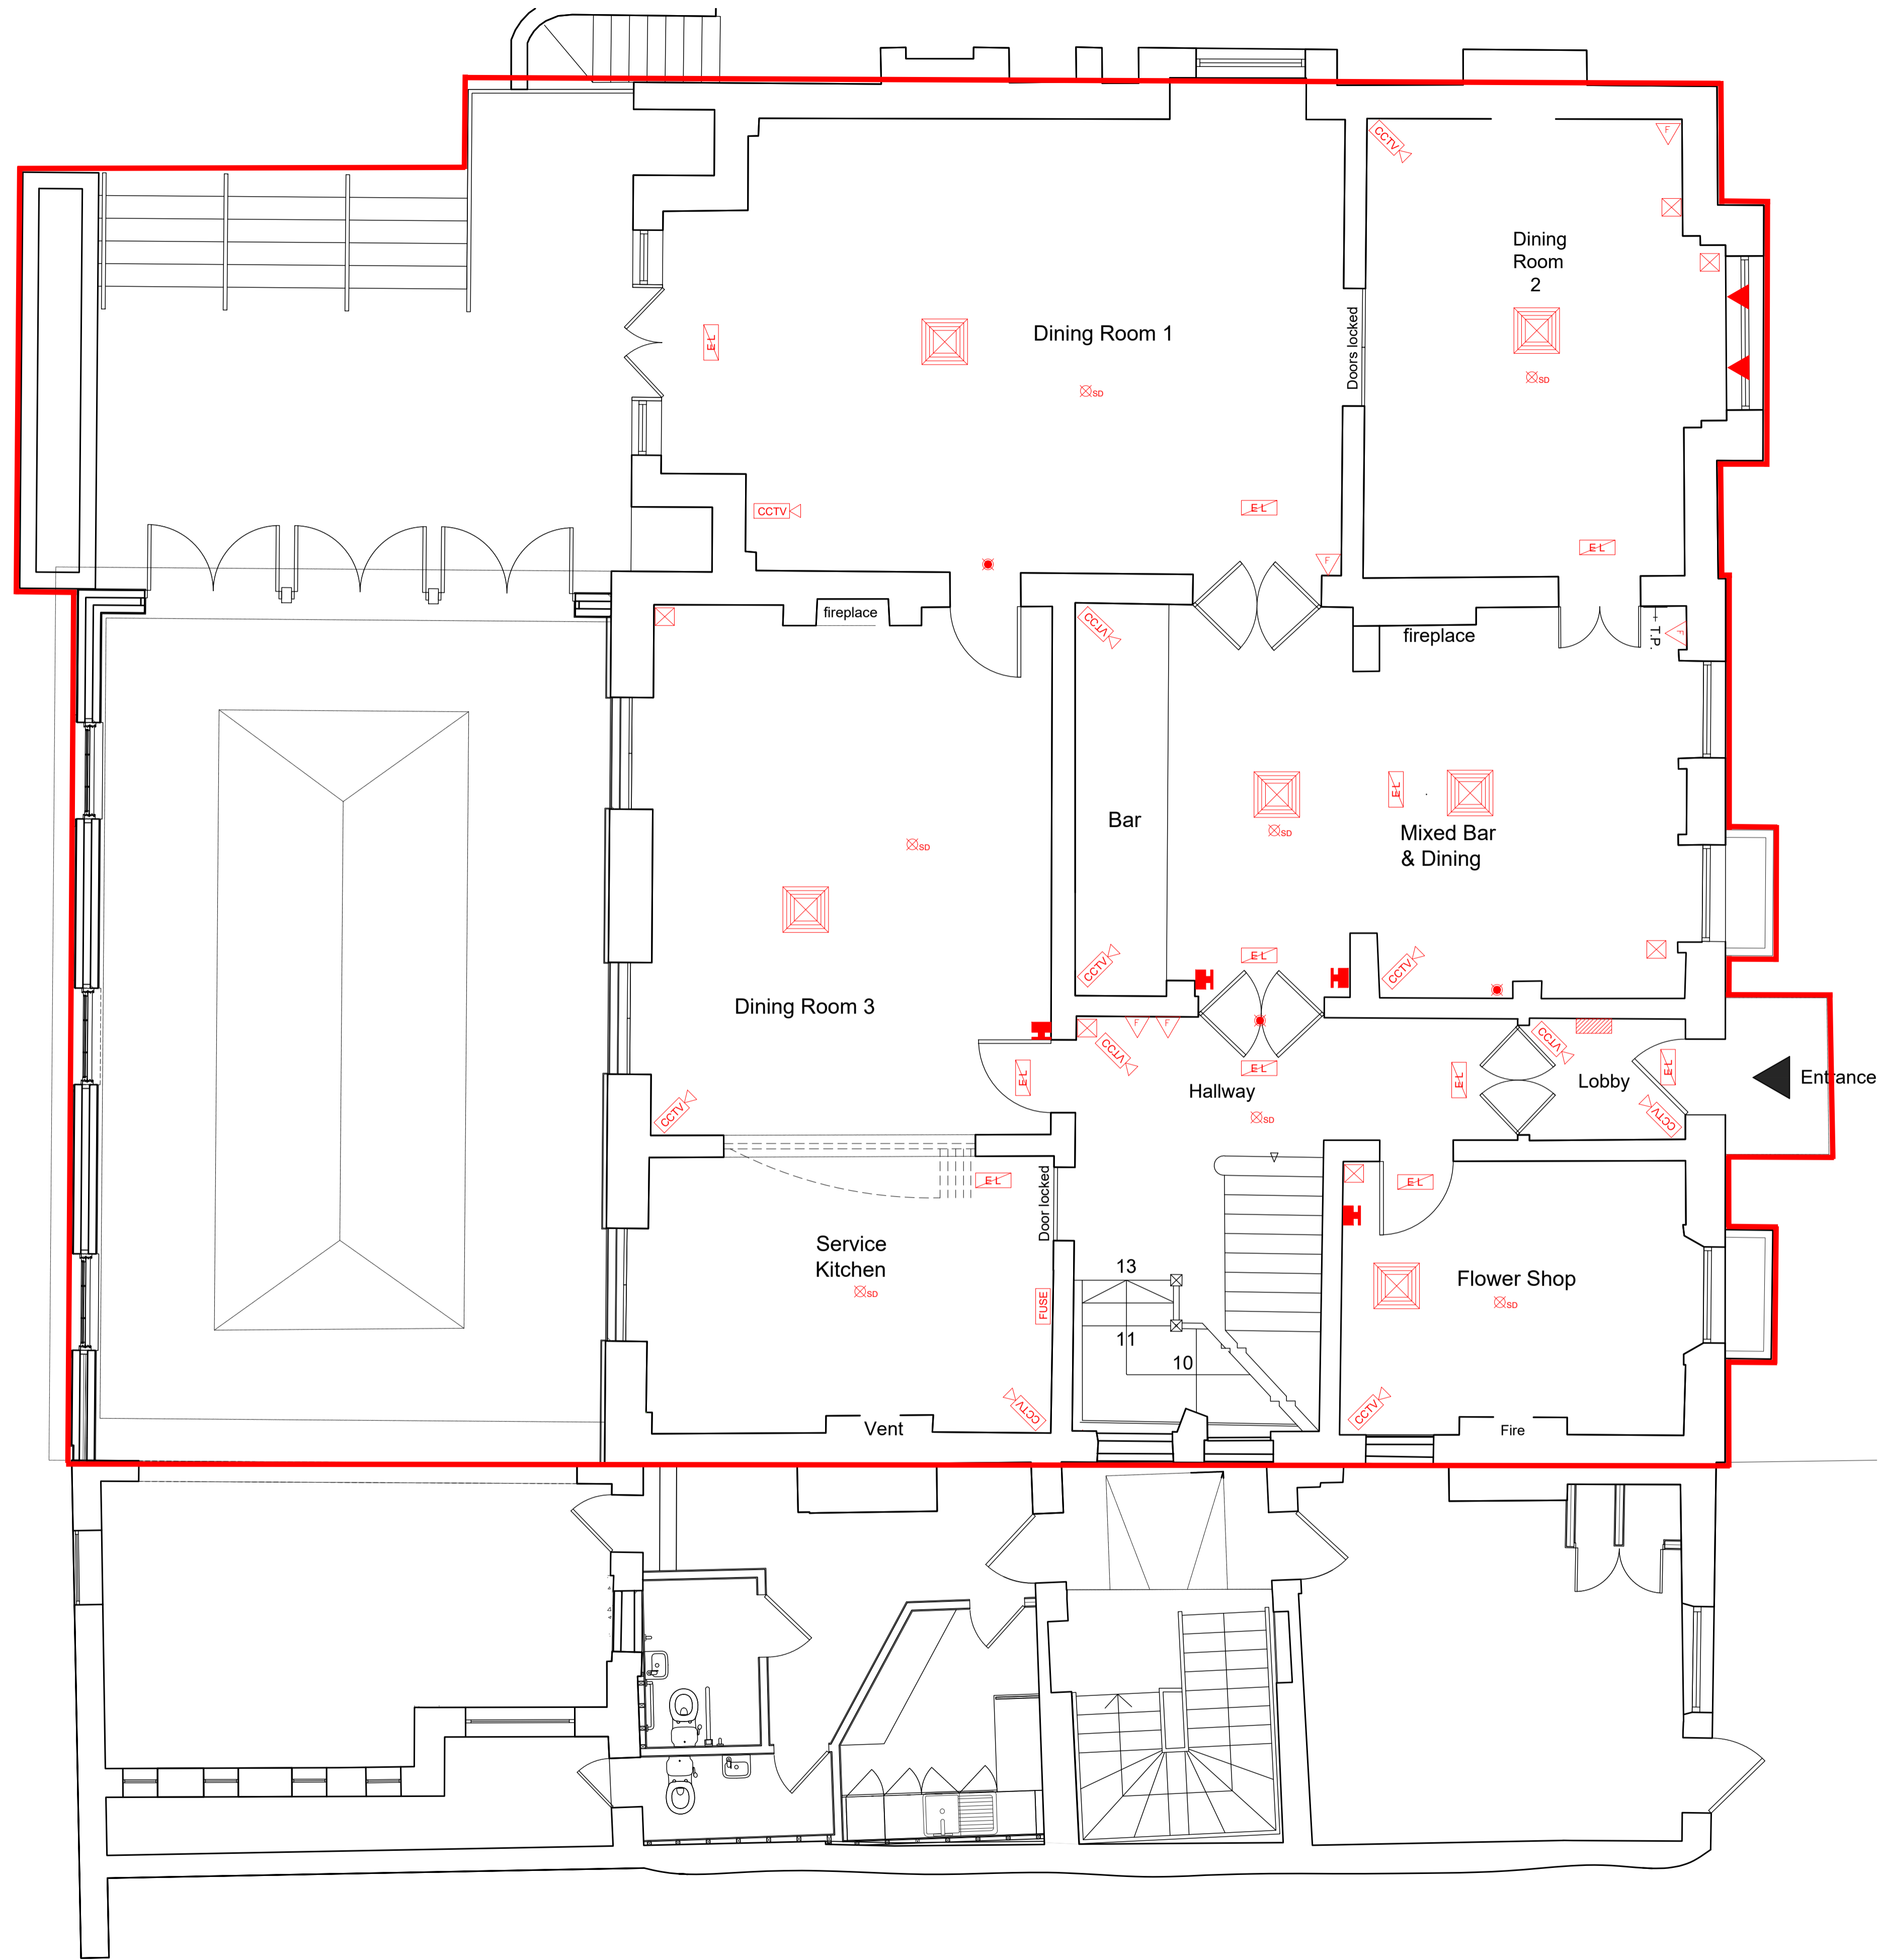

KEY

	CCTV CAMERA		FIRE ALARM CONTROL PANEL
	EMERGENCY LIGHT		BREAK GLASS CALL POINT - LINKED TO FIRE ALARM AUDIBLE WARNING DEVICE
	RED ALARM LIGHT		WALL MOUNTED AIR CON UNIT
	SMOKE DETECTOR		SECURITY ALARM SET PANEL
	FIRE EXTINGUISHER		COMPUTER SERVER UNIT
	AIR CON UNIT CEILING MOUNTED		TELEPHONE POINT
	SECURITY DETECTOR		ELECTRICAL FUSE UNIT
	WINDOW SECURITY DETECTOR		
	MAGNETIC DOOR HOLD OPEN LINKED TO FIRE ALARM		

E-mail michael@admarchitects.co.uk
web site www.admarchitects.co.uk


PROJECT 40, North Street, Chichester		CLIENT Cottrell	
DRAWING TITLE Ground Floor Plan as Proposed		COMPUTER FILE NAME DWG.DWG	
DRAWING NUMBER		ORIGINAL SIZE OF THIS DRAWING IS A1	
DRAWN BD	CHECKED MB	DATE Jan' 2022	SCALE - AS SCALE R/O/S 1:50
PROJECT NUMBER 1766		ACTUAL DRAWING NUMBER SK	
TRINITY, STRETTON, CHICHESTER, WEST SUSSEX, PO18 0LA, UNITED KINGDOM.		TEL. 01243 771166	

ARCHITECTS
DESIGN
&
MANAGEMENT

NOTES: 1. DO NOT SCALE FROM THIS DRAWING (EXCEPT FOR PLANNING APPLICATION PURPOSES). 2. ALL DIMENSIONS AND LEVELS TO BE CHECKED ON SITE BEFORE CARRYING OUT WORK.
3. ALL DISCREPANCIES TO BE REPORTED TO THE ARCHITECT BEFORE CARRYING OUT WORK. 4. READ WITH OTHER CONTRACT DOCUMENTS & IF IN DOUBT ASK.
COPY RIGHT & OWNERSHIP OF THIS DRAWING AND THE DESIGN OF THE BUILDING SHOWN ON THIS DRAWING IS VESTED IN THE ARCHITECTS WHOSE PRIOR WRITTEN CONSENT IS REQUIRED FOR ITS USE, REPRODUCTION OR FOR COPYING TO ANY THIRD PARTY.

© COPYRIGHT - ALL RIGHTS RESERVED

ORIGINAL SIZE OF THIS DRAWING IS A1

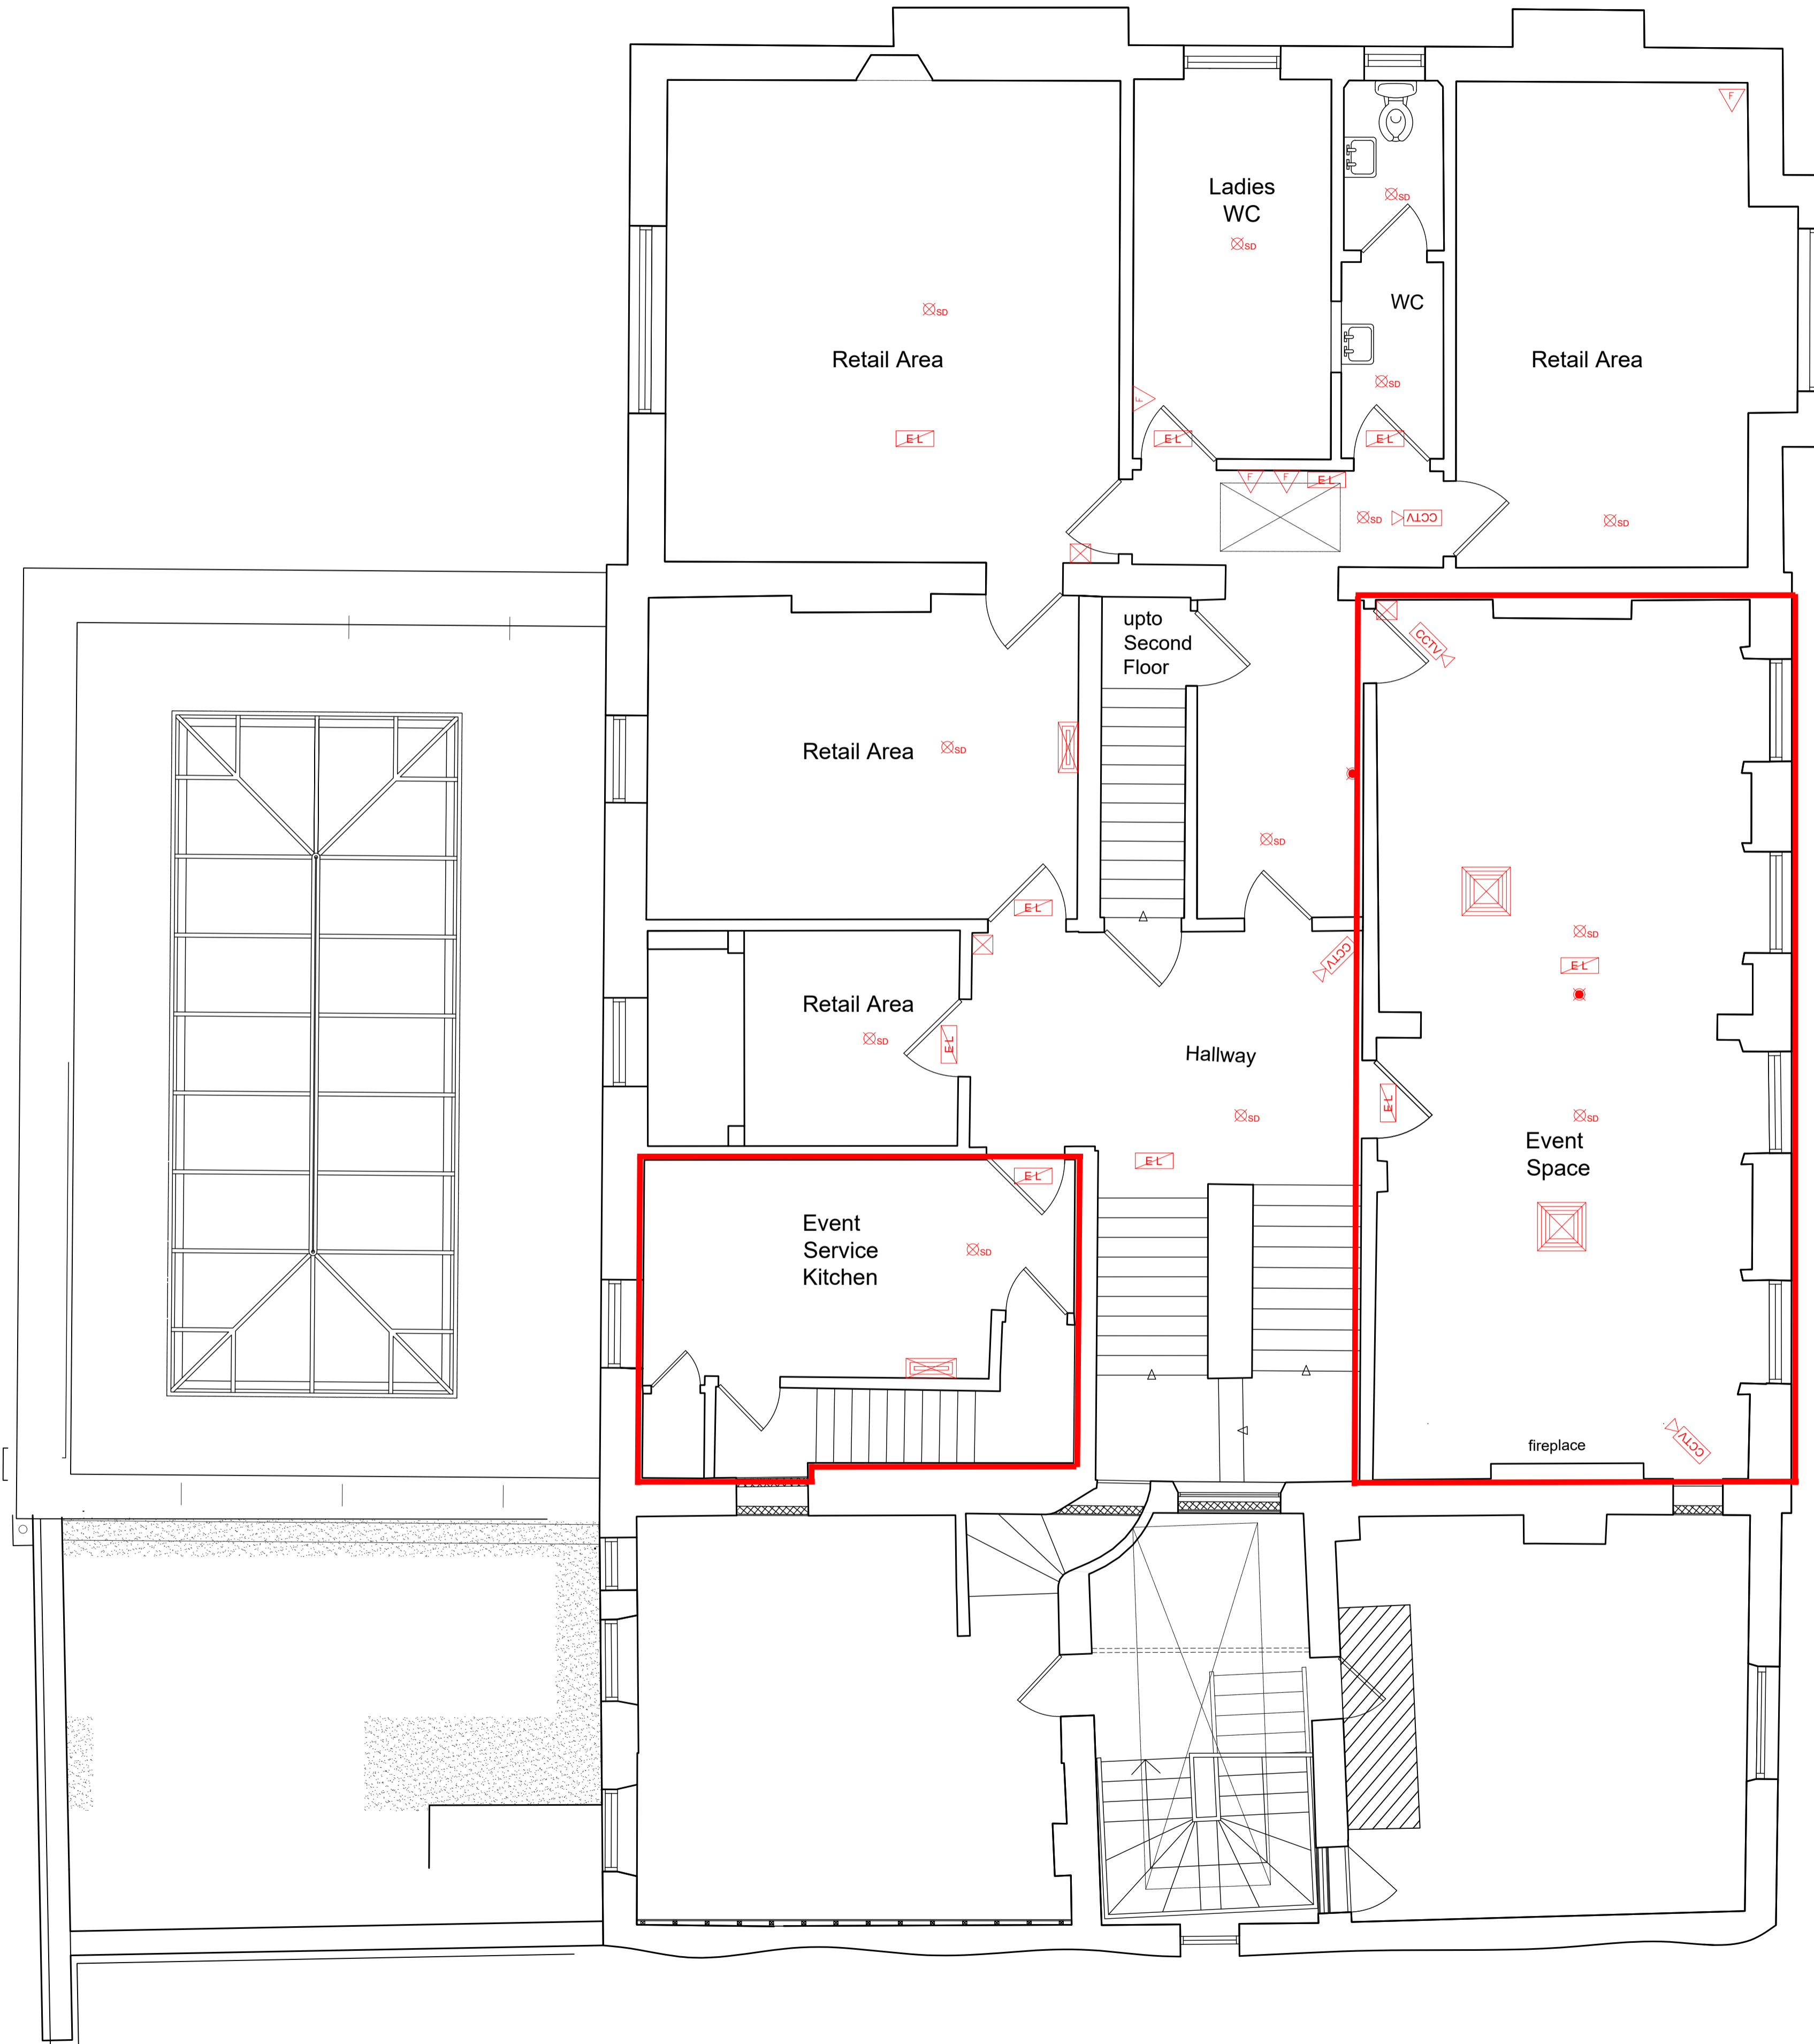

KEY

	CCTV CAMERA		FIRE ALARM CONTROL PANEL
	EMERGENCY LIGHT		BREAK GLASS CALL POINT - LINKED TO FIRE ALARM AUDIBLE WARNING DEVICE
	RED ALARM LIGHT		WALL MOUNTED AIR CON UNIT
	SMOKE DETECTOR		SECURITY ALARM SET PANEL
	FIRE EXTINGUISHER		COMPUTER SERVER UNIT
	AIR CON UNIT CEILING MOUNTED		TELEPHONE POINT
	SECURITY DETECTOR		ELECTRICAL FUSE UNIT
	WINDOW SECURITY DETECTOR		
	MAGNETIC DOOR HOLD OPEN LINKED TO FIRE ALARM		

E-mail michael@admarchitects.co.uk
web site www.admarchitects.co.uk


PROJECT 40, North Street, Chichester				CLIENT Cottrell			
DRAWING TITLE First Floor Plan as Proposed				COMPUTER FILE NAME DWG.DWG			
DRAWING NUMBER				ORIGINAL SIZE OF THIS DRAWING IS A1			
DRWN	CHECKED	DATE	SCALE - AS SCALE R/O/S	PROJECT NUMBER	ACTUAL DRAWING NUMBER	REVISION	
BD	MB	Jan' 2022	1:50	1766	SK	-	
TRINITY, STRETTON, CHICHESTER, WEST SUSSEX, PO18 0LA, UNITED KINGDOM.				TEL. 01243 771166			

ARCHITECTS
DESIGN
&
MANAGEMENT

© COPYRIGHT - ALL RIGHTS RESERVED

REV. | DATE | REVISIONS
NOTES: 1. DO NOT SCALE FROM THIS DRAWING (EXCEPT FOR PLANNING APPLICATION PURPOSES). 2. ALL DIMENSIONS AND LEVELS TO BE CHECKED ON SITE BEFORE CARRYING OUT WORK.
3. ALL DISCREPANCIES TO BE REPORTED TO THE ARCHITECT BEFORE CARRYING OUT WORK. 4. READ WITH OTHER CONTRACT DOCUMENTS S.I.F IN DOUBT ASK.
COPY RIGHT & OWNERSHIP OF THIS DRAWING AND THE DESIGN OF THE BUILDING SHOWN ON THIS DRAWING IS VESTED IN THE ARCHITECTS WHOSE PRIOR WRITTEN
CONSENT IS REQUIRED FOR ITS USE, REPRODUCTION OR FOR COPYING TO ANY THIRD PARTY.

ORIGINAL SIZE OF THIS DRAWING IS A3

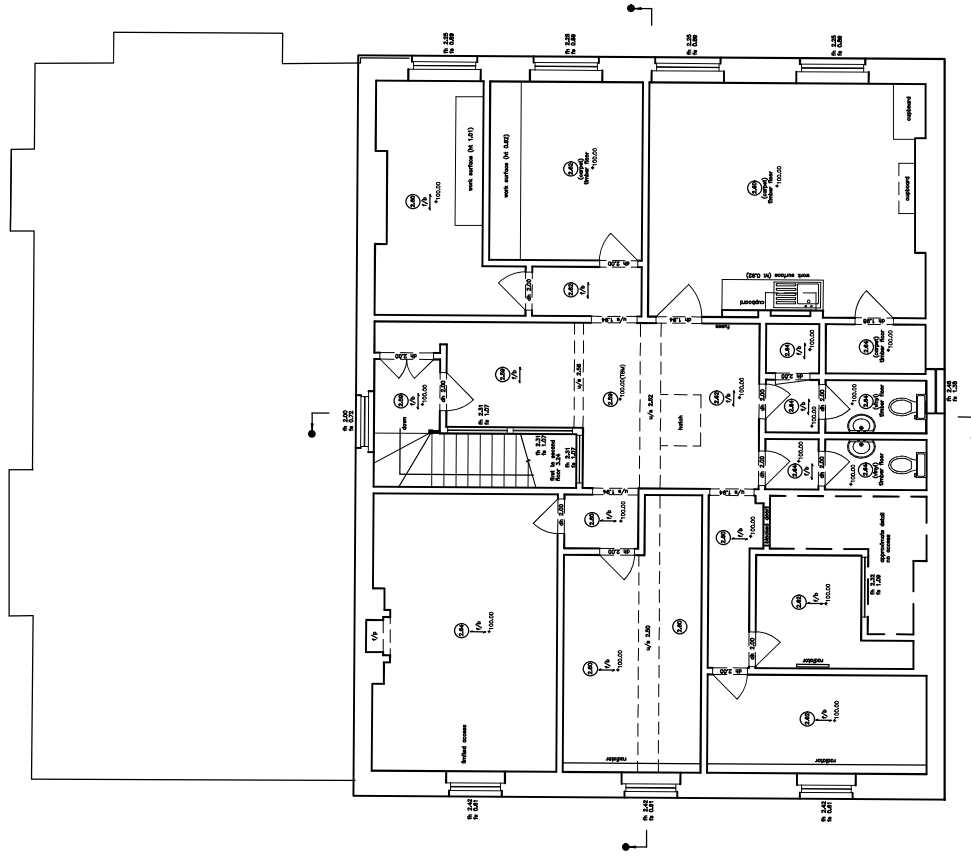

S E C O N D F L O O R

REV. | DATE | REVISIONS

NOTES: 1. DO NOT SCALE FROM THIS DRAWING (EXCEPT FOR PLANNING APPLICATION PURPOSES). 2. ALL DIMENSIONS AND LEVELS TO BE CHECKED ON SITE BEFORE CARRYING OUT WORK. 3. THE CLIENT ACCEPTS THE DESIGN AND THE DESIGN OF THE BUILDING SHOWN ON THIS DRAWING IS VESTED IN THE ARCHITECTS WHOSE PRIOR WRITTEN CONSENT IS REQUIRED FOR ITS USE, REPRODUCTION OR FOR COPYING TO ANY THIRD PARTY.

E-mail: michael@admarchitects.co.uk
 web site: www.admarchitects.co.uk

© COPYRIGHT - ALL RIGHTS RESERVED

PROJECT		CLIENT	
40, North Street, Chichester		Cottrell	
DRAWING TITLE		COMPUTER FILE NAME	
Second Floor Plan as Existing		DWGLDWG	
DRAWN		ORIGINAL SIZE OF THIS DRAWING IS A3	
BD		DRAWING NUMBER	
MB		PROJECT NUMBER	
Jan' 2022		1766	
SCALE - AS SCALE RDS		ACTUAL DRAWING NUMBER	
1:100		SK	
TRINITY, STRETTONING, CHICHESTER, WEST SUSSEX, PO18 0LA, UNITED KINGDOM.		TEL: 01243 771166	
		ARCHITECTS DESIGN & MANAGEMENT	